


WORKING DRAWING
OF
PROPOSED: 1(ONE) STORIED TIN ROOFED BUILDING &
SAFE DRINKING WATER POINT.
FOR
ISLAMPUR DAKHIL MADRASH
DISRTICT. MOULVIBAZAR, UPZ. KAMALGANJ.

IMPLEMENTED BY
GOOD NEIGHBORS
BANGLADESH


MOULVIBAZAR CDP

DESIGN BY
Engr. Jaber Al Sabet.
Technical Facilitator
Good Neighbors Bangladesh
Moulvi Bazar CDP.
CALL:01613-080824

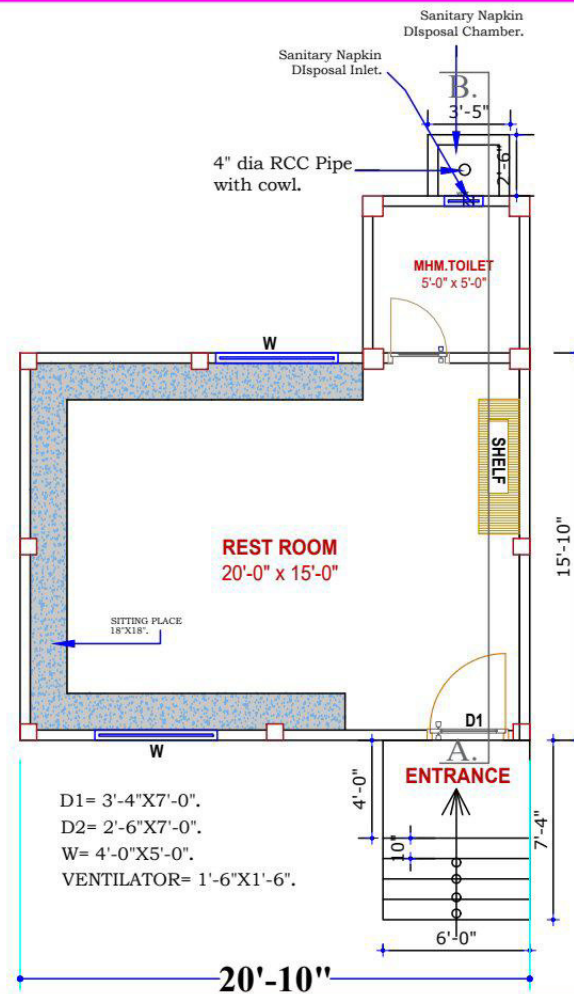


PAGE NO - 01

	PROJECT NAME.	ACTIVITIES NAME.	ACKNOWLEDGE BY.	DESIGN BY.
	Promoting Safe drinking water source and Menstrual Hygiene Management Facilities for Adolescents in school level at Moulvibazar CDP	Establish Adolescent Corner.	Education Protection & Health Team	Engr. Jaber Al Sabet. Technical Facilitator Good Neighbors Bangladesh Moulvi Bazar CDP. CALL:01613-080824
	PROJECT LOCATION.	DRAWING TITLE.		
	Islampur Dakhil Madrasah At Islampur, Kamalganj, Moulvibazar.	FLOOR PLAN		
		DATE: July- 2026	SCALE: AS SHOWN	

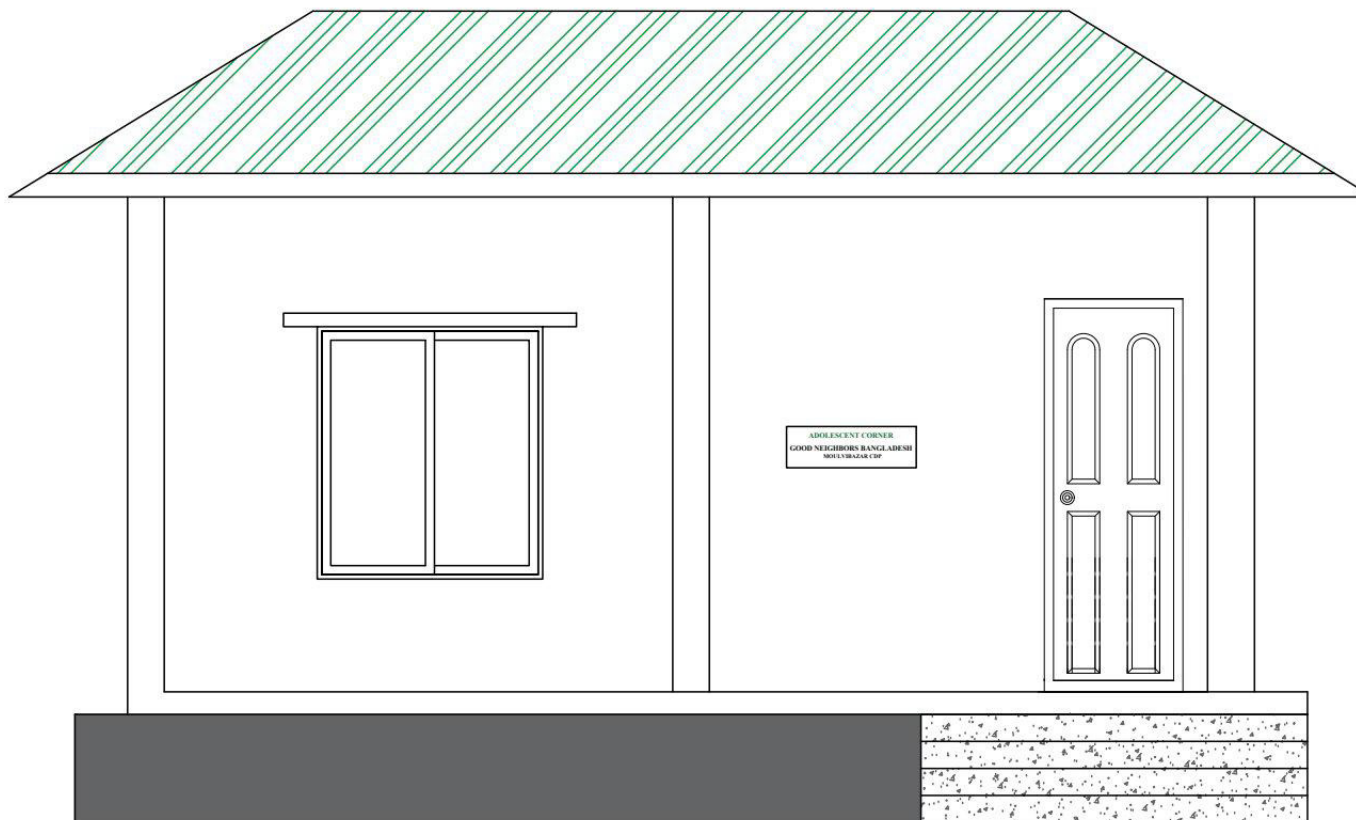

PAGE NO - 02


	PROJECT NAME.	ACTIVITIES NAME.	ACKNOWLEDGE BY.	DESIGN BY.
	Promoting Safe drinking water source and Menstrual Hygiene Management Facilities for Adolescents in school level at Moulvibazar CDP	Establish Adolescent Corner.	Education Protection & Health Team	Engr. Jaber Al Sabet. Technical Facilitator Good Neighbors Bangladesh Moulvi Bazar CDP. CALL:01613-080824
	PROJECT LOCATION.	DRAWING TITLE.		
	Islampur Dakhil Madrasah At Islampur,Kamalganj,Moulvibazar.	FRONT ELEVATION		
			DATE: July- 2026	SCALE: AS SHOWN

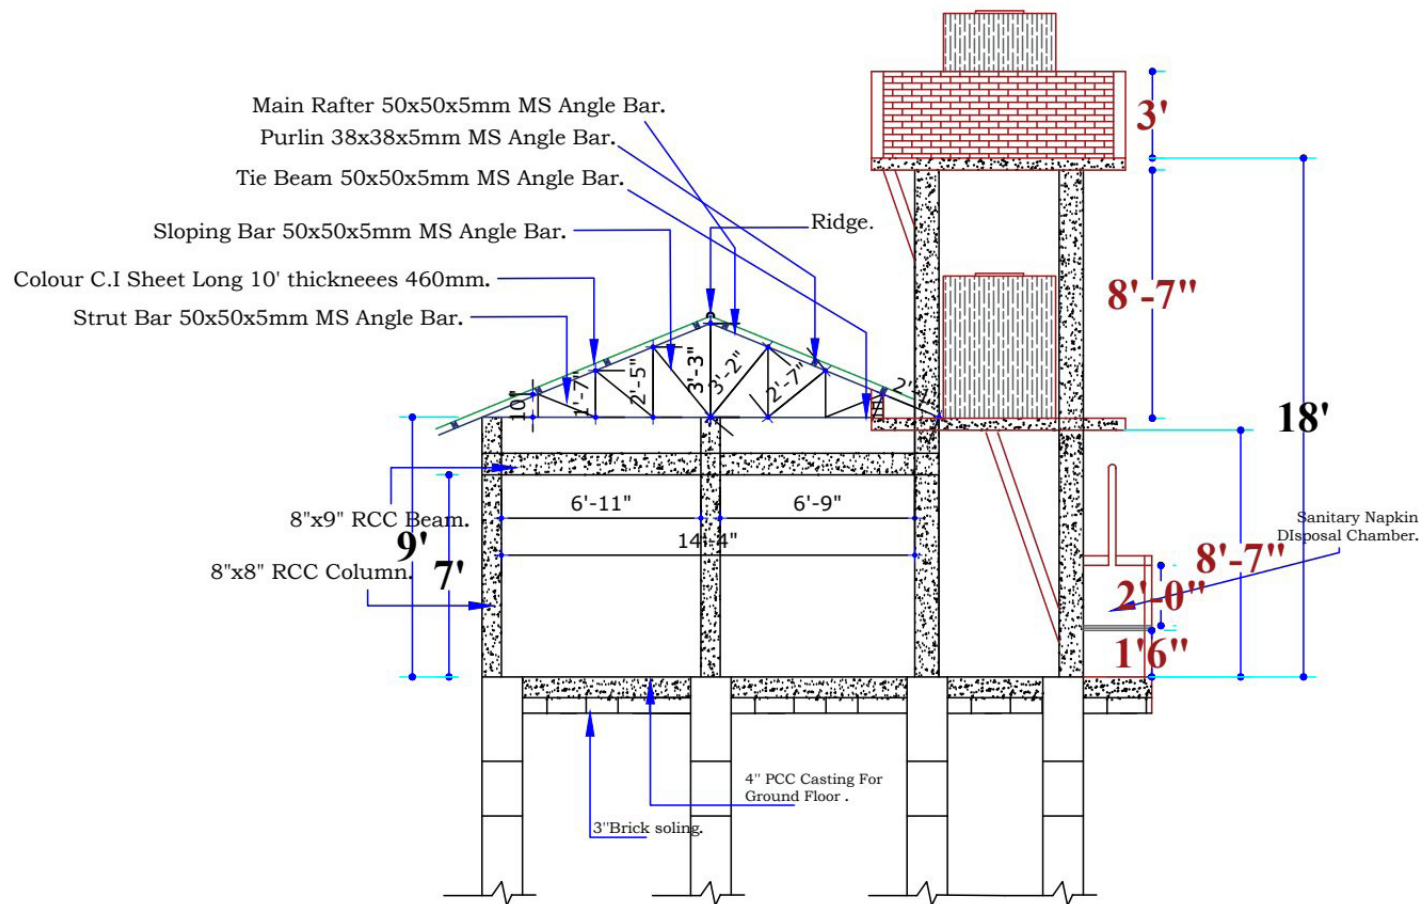

SECTION -A B

PAGE NO - 03

	PROJECT NAME.	ACTIVITIES NAME.	ACKNOWLEDGE BY.	DESIGN BY.
	Promoting Safe drinking water source and Menstrual Hygiene Management Facilities for Adolescents in school level at Moulvibazar CDP.	Establish Adolescent Corner.	Education Protection & Health Team	Engr. Jaber Al Sabet. Technical Facilitator Good Neighbors Bangladesh Moulvi Bazar CDP. CALL:01613-080824
	PROJECT LOCATION.	DRAWING TITLE.		
	Islampur Dakhil Madrasah At Islampur, Kamalganj, Moulvibazar.	SECTIONAL PLAN		
			DATE: July- 2026	SCALE: AS SHOWN

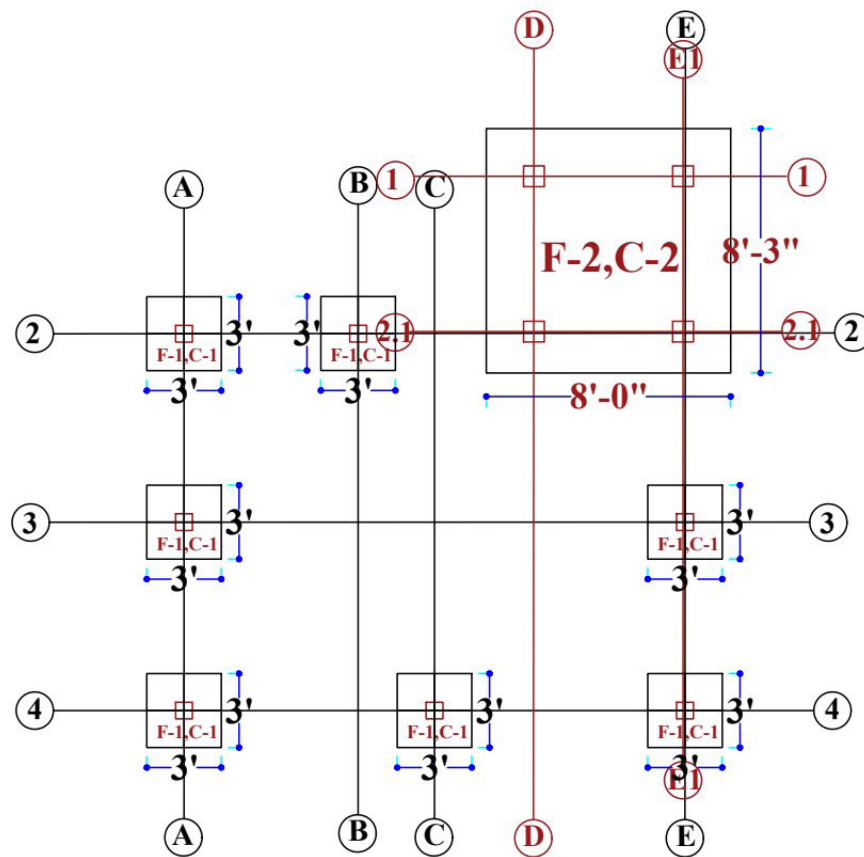


PAGE NO - 05

	PROJECT NAME.	ACTIVITIES NAME.	ACKNOWLEDGE BY.	DESIGN BY.
	Promoting Safe drinking water source and Menstrual Hygiene Management Facilities for Adolescents in school level at Moulvibazar CDP	Establish Adolescent Corner.	Education Protection & Health Team	Engr. Jaber Al Sabet. Technical Facilitator Good Neighbors Bangladesh Moulvi Bazar CDP. CALL:01613-080824
	PROJECT LOCATION.	DRAWING TITLE.		
	Islampur Dakhil Madrasah At Islampur, Kamalganj, Moulvibazar.	FOOTING & COLUMN LAYOUT PLAN	DATE: July- 2026 SCALE: AS SHOWN	


COLUMN SCHEDULE		
COLUMN TYPE	BELOW GROUND FLOOR	ABOVE GROUND FLOOR
C1-7 NOS	 02 - Ø 12 mm 02 - Ø 10 mm	 02 - Ø 12 mm 02 - Ø 10 mm
C2-4 NOS	 04 - Ø 16 mm	 04 - Ø 16 mm

C1-tie use 8 mm rod
C2-tie use 10 mm rod

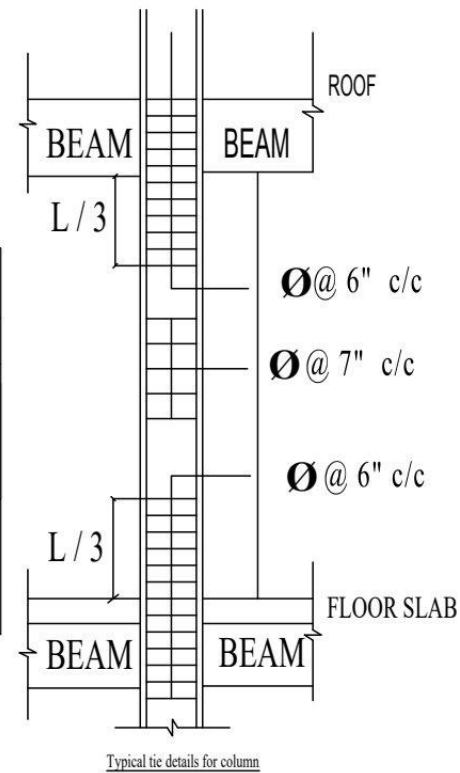


PAGE NO - 07

	PROJECT NAME:	ACTIVITIES NAME:	ACKNOWLEDGE BY:	DESIGN BY:
	Promoting Safe drinking water source and Menstrual Hygiene Management Facilities for Adolescents in school level at Moulvibazar CDP	Establish Adolescent Corner.	Education Protection & Health Team	Engr. Jaber Al Sabet. Technical Facilitator Good Neighbors Bangladesh Moulvi Bazar CDP. CALL:01613-080824
	PROJECT LOCATION:	DRAWING TITLE:	DATE: July 2025	SCALE: AS SHOWN
	Islampur Dakhil Madrasah At Islampur, Kamalganj, Moulvibazar.	COLUMN DETAIL PLAN		

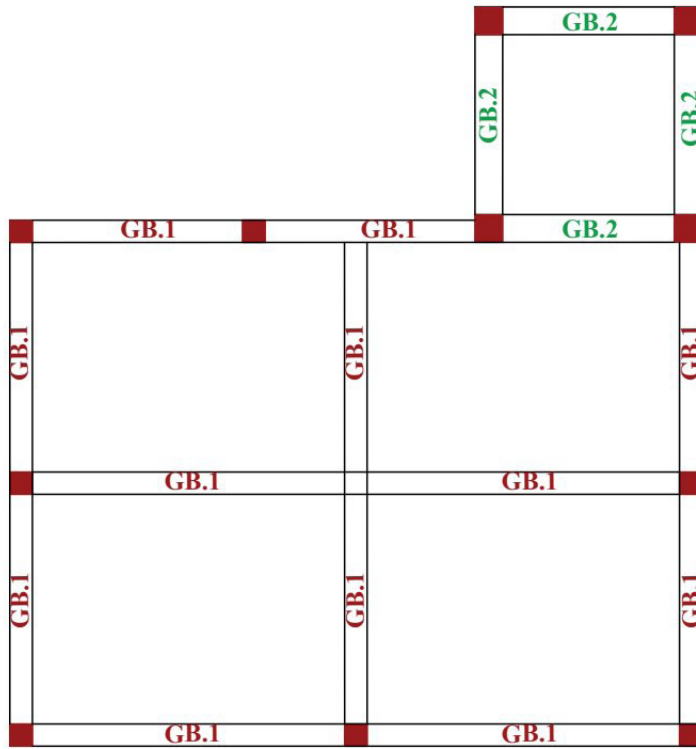


DRAWING TITLE:
GRADE BEAM LAYOUT
PLAN

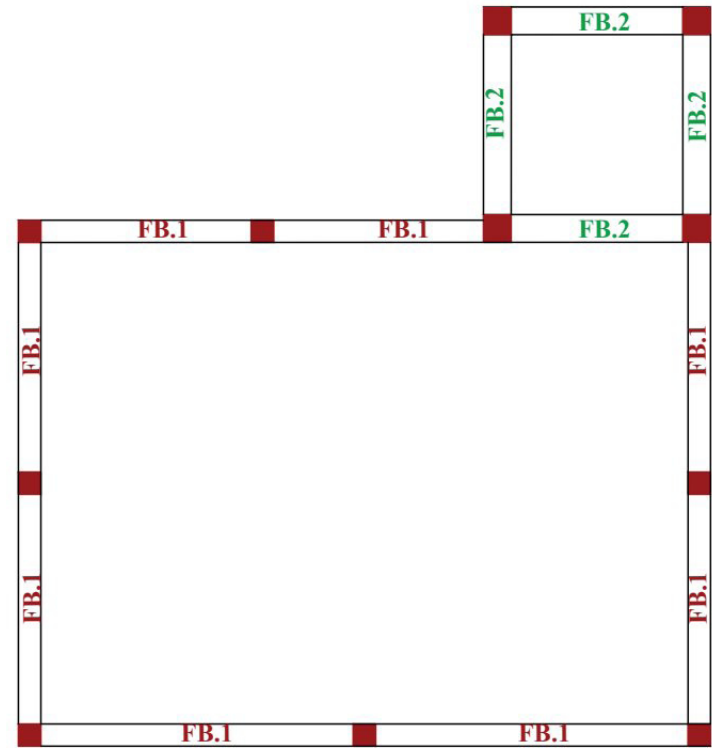


DRAWING TITLE:
F BEAM LAYOUT PLAN

PAGE NO - 08


	PROJECT NAME.	ACTIVITIES NAME.	ACKNOWLEDGE BY.	DESIGN BY.
	Promoting Safe drinking water source and Menstrual Hygiene Management Facilities for Adolescents in school level at Moulvibazar CDP	Establish Adolescent Corner.	Education Protection & Health Team	Engr. Jaber Al Sabet. Technical Facilitator Good Neighbors Bangladesh Moulvi Bazar CDP. CALL:01613-080824
	PROJECT LOCATION.	DRAWING TITLE.		
	Islampur Dakhil Madrasah At Islampur,Kamalganj,Moulvibazar.	BEAM LAYOUT PLAN		
		DATE: July- 2026	SCALE: AS SHOWN	

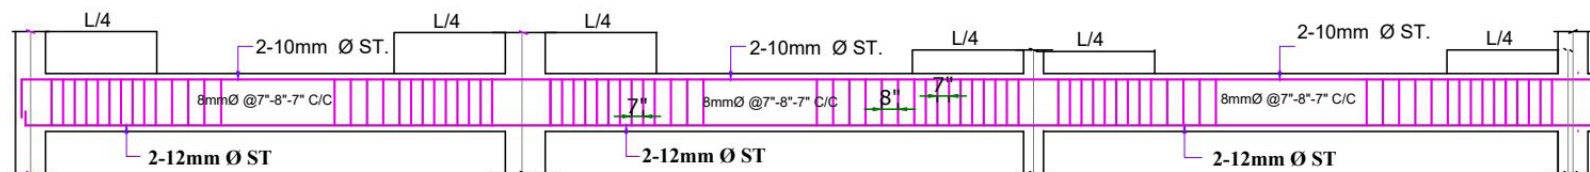


Section of G.B (8"x10")

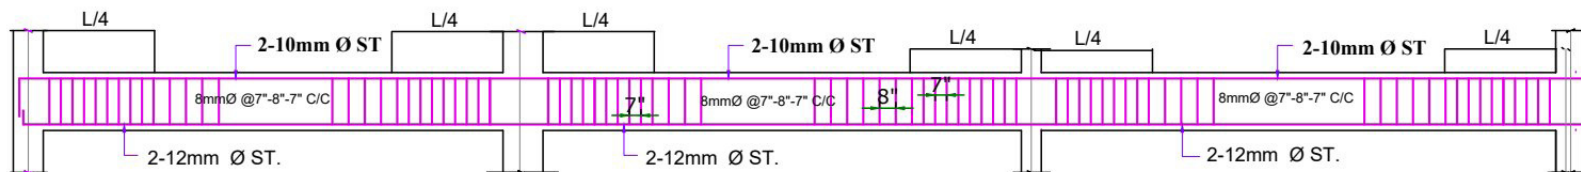

Section of F.B- (8"x9")

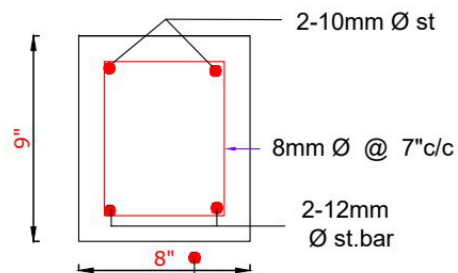


Section of F.B.-1

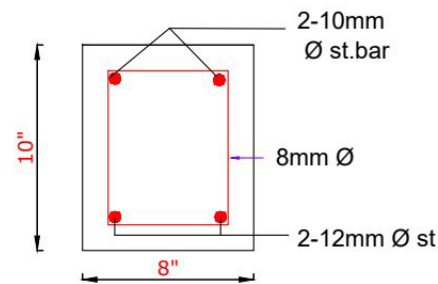


Section of G.B.1

PAGE NO - 09


	PROJECT NAME.	ACTIVITIES NAME.	ACKNOWLEDGE BY.	DESIGN BY.
	Promoting Safe drinking water source and Menstrual Hygiene Management Facilities for Adolescents in school level at Moulvibazar CDP	Establish Adolescent Corner.	Education Protection & Health Team	Engr. Jaber Al Sabet. Technical Facilitator Good Neighbors Bangladesh Moulvi Bazar CDP. CALL:01613-080824
	PROJECT LOCATION.	DRAWING TITLE.		
	Islampur Dakhil Madrasah At Islampur,Kamalganj,Moulvibazar.	BEAM DETAIL PLAN	DATE: July- 2026	SCALE: AS SHOWN

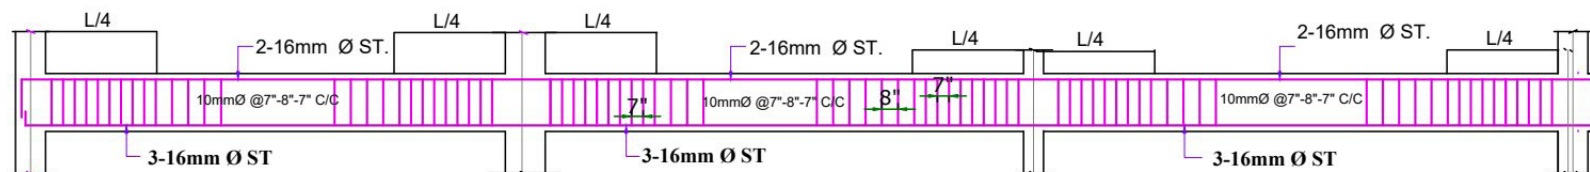


Section of G.B- 2

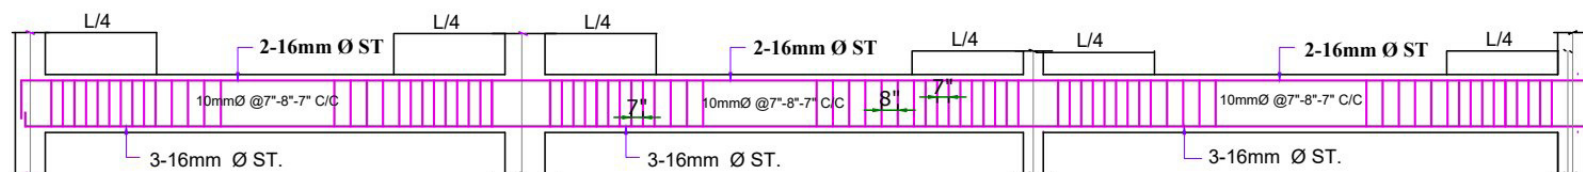

Section of F.B-2

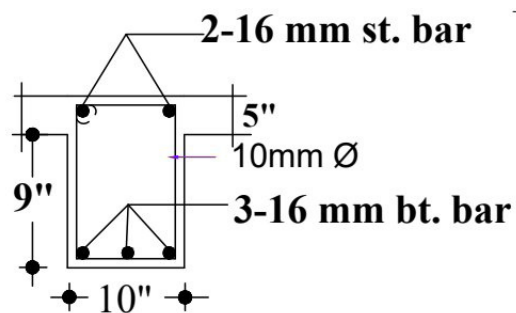


Section of F.B.-2

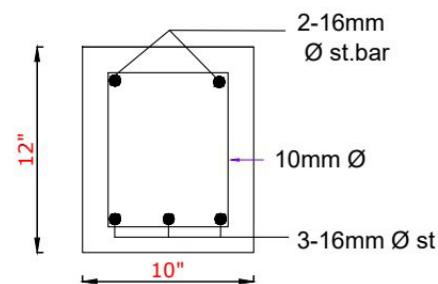

Section of G.B.2


PAGE NO - 10

	PROJECT NAME.	ACTIVITIES NAME.	ACKNOWLEDGE BY.	DESIGN BY.
	Promoting Safe drinking water source and Menstrual Hygiene Management Facilities for Adolescents in school level at Moulvibazar CDP	Establish Adolescent Corner.	Education Protection & Health Team	Engr. Jaber Al Sabet. Technical Facilitator Good Neighbors Bangladesh Moulvi Bazar CDP. CALL:01613-080824
	PROJECT LOCATION.	DRAWING TITLE.		
	Islampur Dakhil Madrasah At Islampur, Kamalganj, Moulvibazar.	BEAM DETAIL PLAN	DATE: July- 2026 SCALE: AS SHOWN	

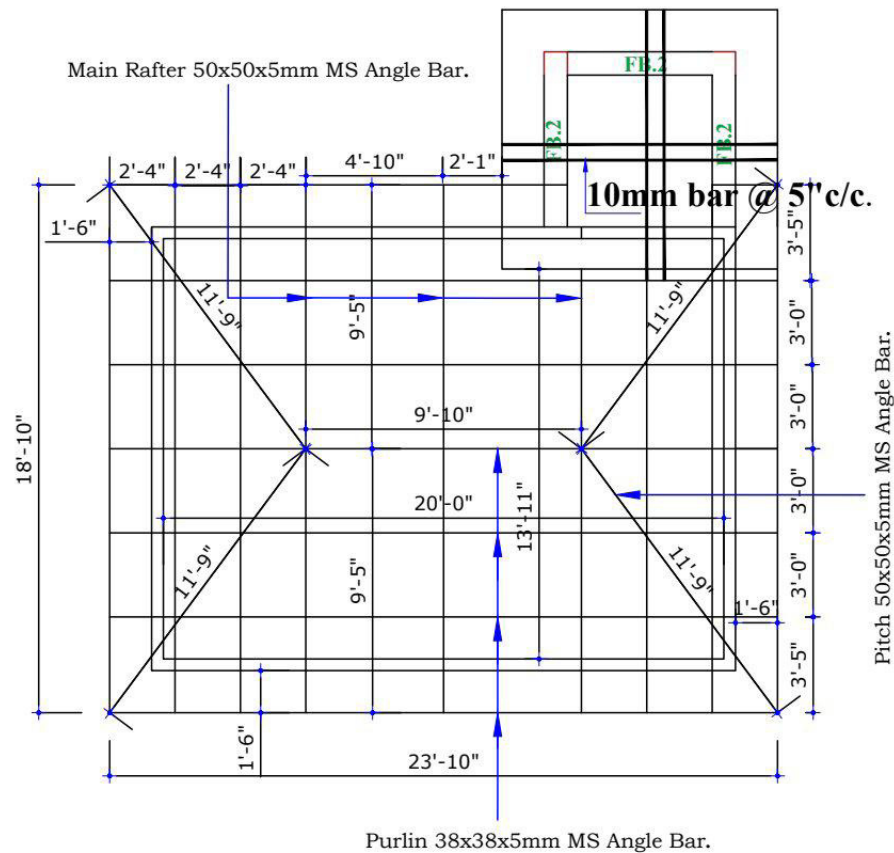


PAGE NO - 11

	PROJECT NAME.	ACTIVITIES NAME.	ACKNOWLEDGE BY.	DESIGN BY.
	Promoting Safe drinking water source and Menstrual Hygiene Management Facilities for Adolescents in school level at Moulvibazar CDP	Establish Adolescent Corner.	Education Protection & Health Team	Engr. Jaber Al Sabet. Technical Facilitator Good Neighbors Bangladesh Moulvi Bazar CDP. CALL:01613-080824
	PROJECT LOCATION.	DRAWING TITLE.	DATE: July, 2026	SCALE: AS SHOWN
	Islampur Dakhil Madrasah At Islampur, Kamalganj, Moulvibazar.	ROOF PLAN		

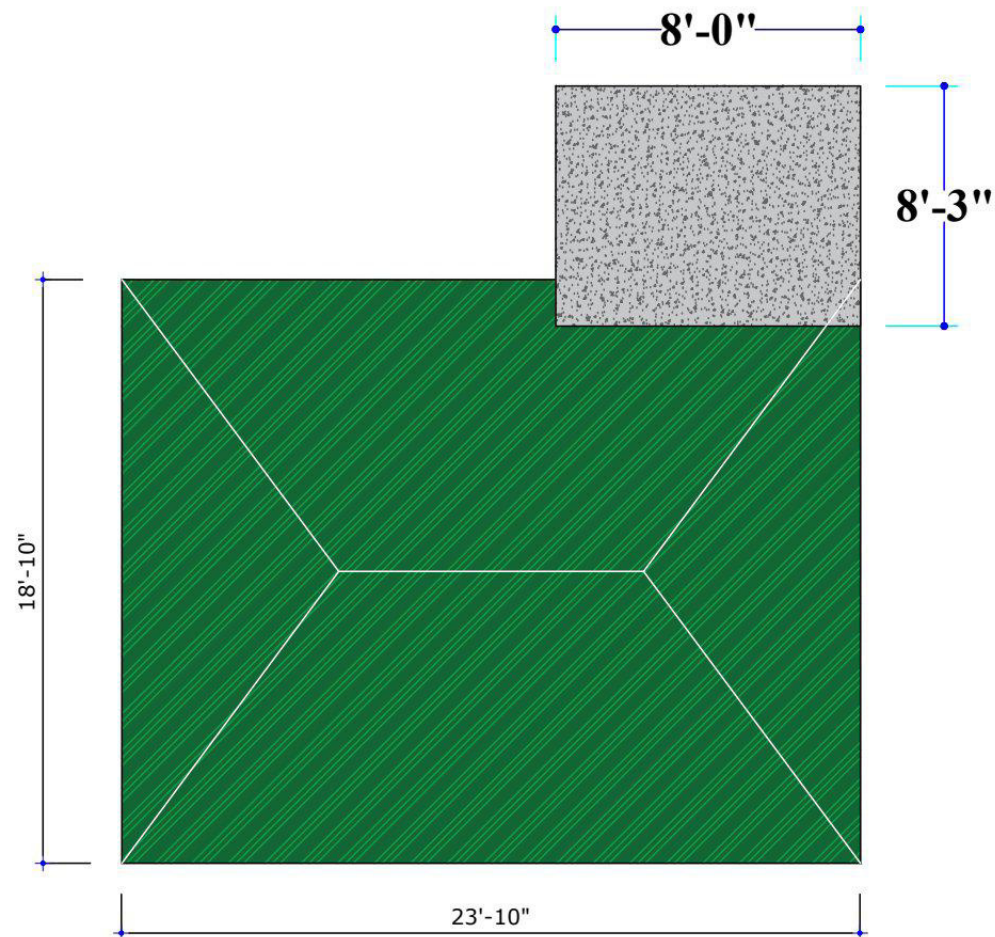

PAGE NO - 12


	PROJECT NAME.	ACTIVITIES NAME.	ACKNOWLEDGE BY.	DESIGN BY.
	Promoting Safe drinking water source and Menstrual Hygiene Management Facilities for Adolescents in school level at Moulvibazar CDP	Establish Adolescent Corner.	Education Protection & Health Team	Engr. Jaber Al Sabet. Technical Facilitator Good Neighbors Bangladesh Moulvi Bazar CDP. CALL:01613-080824
	PROJECT LOCATION.	DRAWING TITLE.		
	Islampur Dakhil Madrasah At Islampur,Kamalganj,Moulvibazar.	ROOF TOP VIEW		

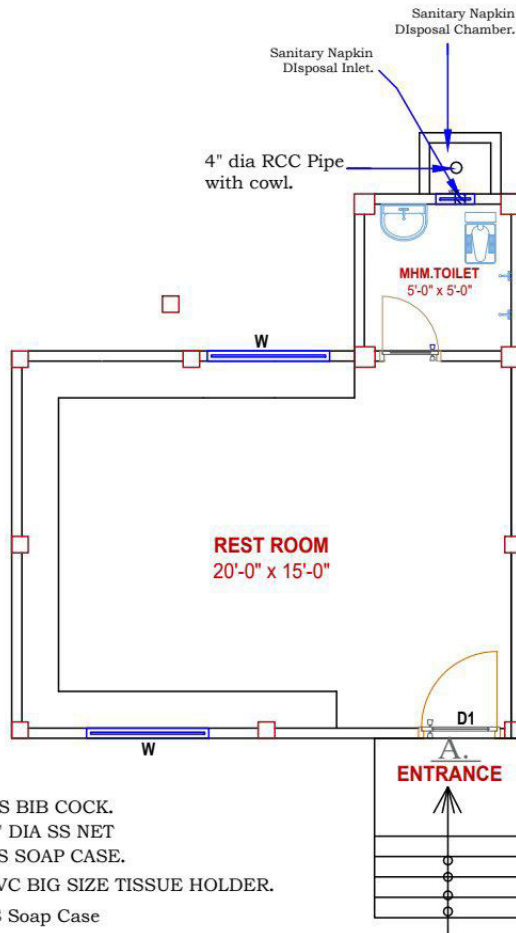

02 NOS SS BIB COCK.
 01 NOS 4" DIA SS NET
 01 NOS SS SOAP CASE.
 01 NOS PVC BIG SIZE TISSUE HOLDER.
 01 Nos SS Soap Case
 01 Nos 16" x 22" Glass with Self
 01 Nos WASH BASIN 18"X14"

PAGE NO - 13

 Good Neighbors Bangladesh	PROJECT NAME.	ACTIVITIES NAME.	ACKNOWLEDGE BY.	DESIGN BY.
	Promoting Safe drinking water source and Menstrual Hygiene Management Facilities for Adolescents in school level at Moulvibazar CDP	Establish Adolescent Corner.	Education Protection & Health Team	Engr. Jaber Al Sabet. Technical Facilitator Good Neighbors Bangladesh Moulvi Bazar CDP. CALL:01613-080824
	PROJECT LOCATION.	DRAWING TITLE.	 DATE: July- 2026 SCALE: AS SHOWN	
	Islampur Dakhil Madrasah At Islampur, Kamalganj, Moulvibazar.	PLUMBING PLAN		

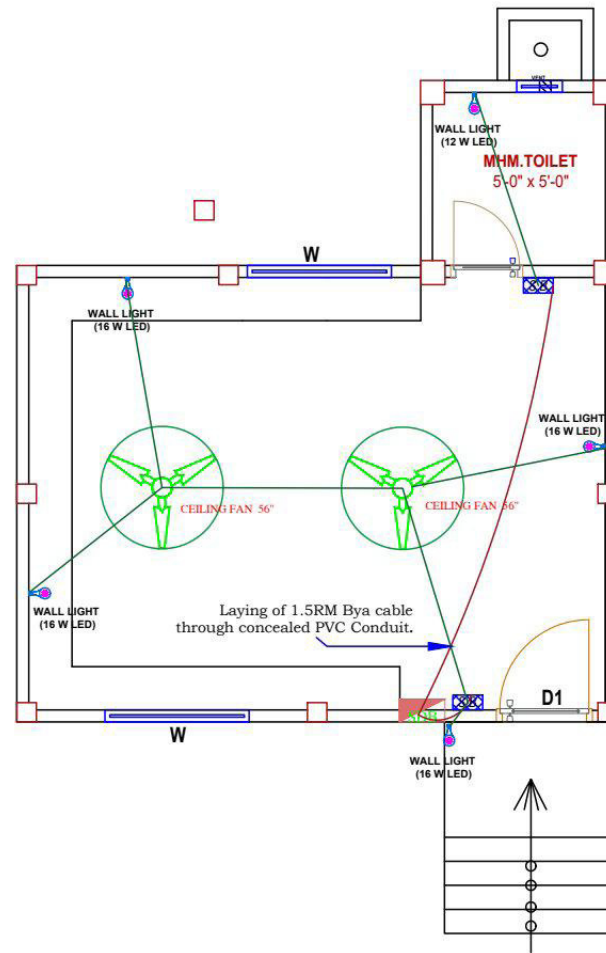

PAGE NO - 14

	PROJECT NAME.	ACTIVITIES NAME.	ACKNOWLEDGE BY.	DESIGN BY.
	Promoting Safe drinking water source and Menstrual Hygiene Management Facilities for Adolescents in school level at Moulvibazar CDP	Establish Adolescent Corner.	Education Protection & Health Team	Engr. Jaber Al Sabet. Technical Facilitator Good Neighbors Bangladesh Moulvi Bazar CDP. CALL:01613-080824
	PROJECT LOCATION.	DRAWING TITLE.	 DATE: July- 2026 SCALE: AS SHOWN	
	Islampur Dakhil Madrasah At Islampur, Kamalganj, Moulvibazar.	ELECTRICAL PLAN		