


WORKING DRAWING
OF
PROPOSED:1(ONE) STORIED TIN ROOFED BUILDING
FOR
KURMA TEA GARDEN JR. SCHOOL
DISRTICT. MOULVIBAZAR, UPZ . KAMALGANJ.

IMPLEMENTED BY
GOOD NEIGHBORS
BANGLADESH


MOULVIBAZAR CDP

DESIGN BY
Engr. Jaber Al Sabet.
Technical Facilitator
Good Neighbors Bangladesh
Moulvi Bazar CDP.
CALL:01613-080824

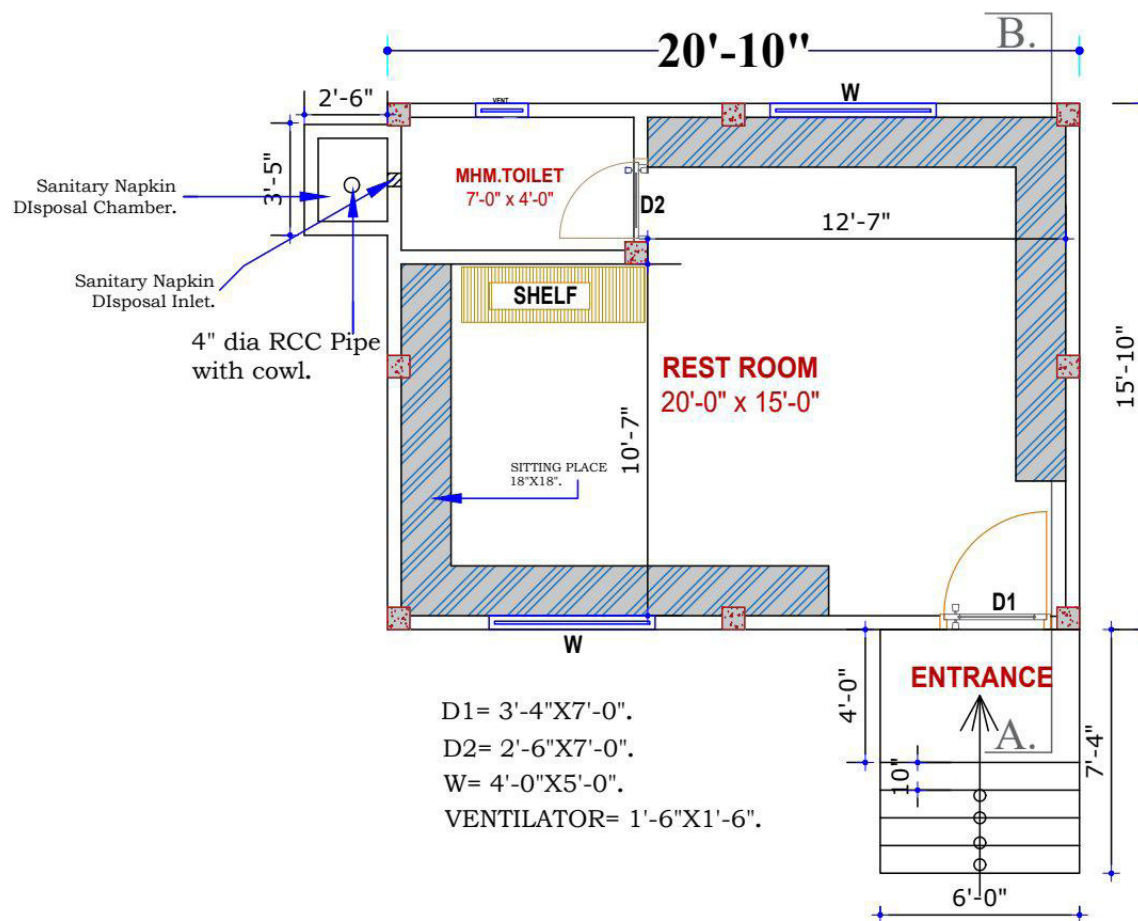


PAGE NO - 01

	PROJECT NAME.	ACTIVITIES NAME.	ACKNOWLEDGE BY.	DESIGN BY.
	Promoting Safe drinking water source and Menstrual Hygiene Management Facilities for Adolescents in school level at Moulvibazar CDP	Establish Adolescent Corner.	Education Protection & Health Team	Engr. Jaber Al Sabet. Technical Facilitator Good Neighbors Bangladesh Moulvi Bazar CDP. CALL:01613-080824
	PROJECT LOCATION.	DRAWING TITLE.	 DATE: July- 2026 SCALE: AS SHOWN	
	Kurma Tea garden Jr. School At Islampur,Kamalganj,Moulvibazar.	FLOOR PLAN		

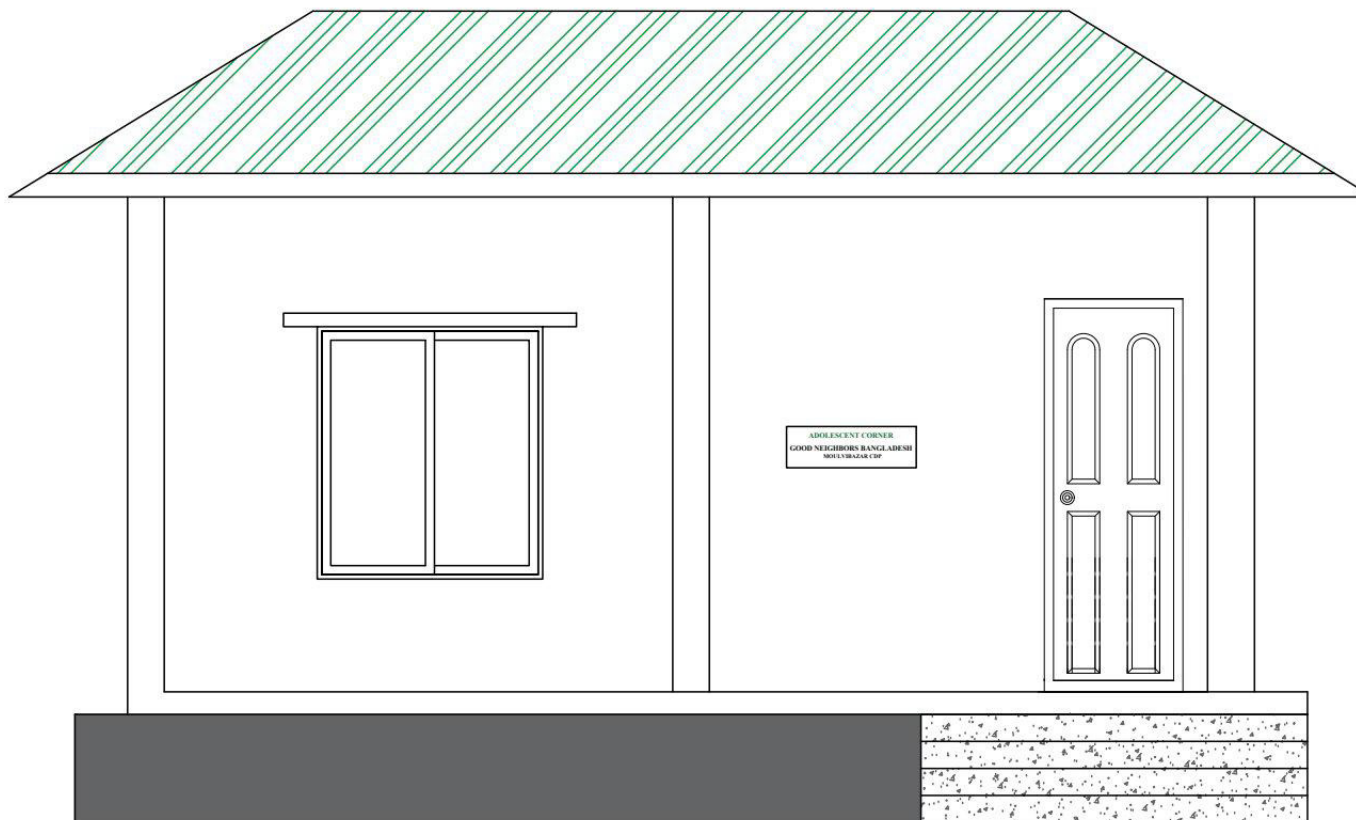

PAGE NO - 02


	PROJECT NAME.	ACTIVITIES NAME.	ACKNOWLEDGE BY.	DESIGN BY.
	Promoting Safe drinking water source and Menstrual Hygiene Management Facilities for Adolescents in school level at Moulvibazar CDP	Establish Adolescent Corner.	Education Protection & Health Team	Engr. Jaber Al Sabet. Technical Facilitator Good Neighbors Bangladesh Moulvi Bazar CDP. CALL:01613-080824
	PROJECT LOCATION.	DRAWING TITLE.		
	Kurma Tea garden Jr. School At Islampur,Kamalganj,Moulvibazar.	FRONT ELEVATION		
			DATE: July- 2026	SCALE: AS SHOWN

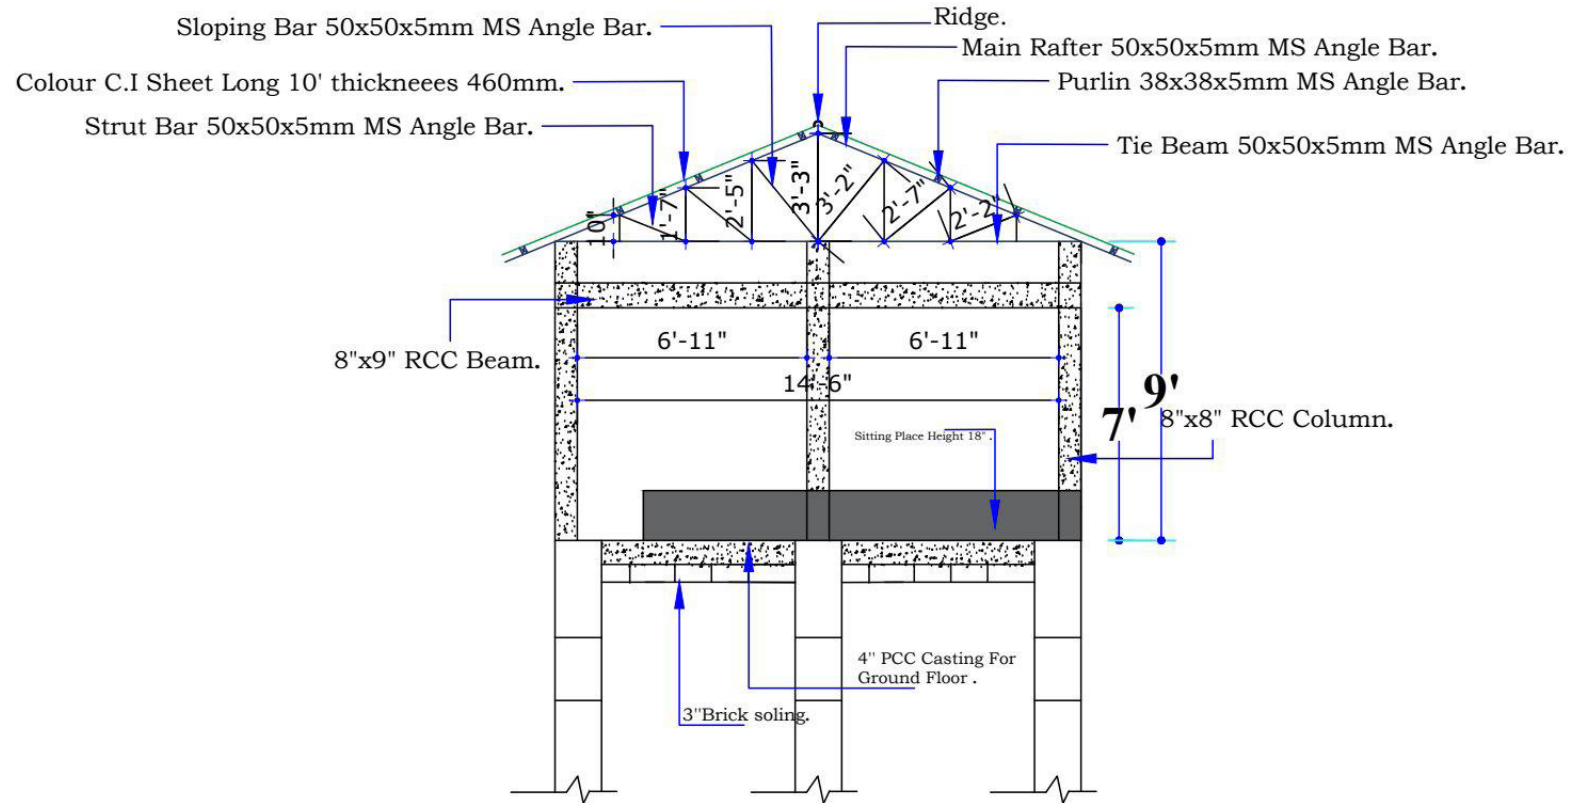

SECTION - A B


PAGE NO - 03

	PROJECT NAME.	ACTIVITIES NAME.	ACKNOWLEDGE BY.	DESIGN BY.
	Promoting Safe drinking water source and Menstrual Hygiene Management Facilities for Adolescents in school level at Moulvibazar CDP.	Establish Adolescent Corner.	Education Protection & Health Team	Engr. Jaber Al Sabet. Technical Facilitator Good Neighbors Bangladesh Moulvi Bazar CDP. CALL:01613-080824
	PROJECT LOCATION.	DRAWING TITLE.	 DATE: July- 2026 SCALE: AS SHOWN	
	Kurma Tea garden Jr. School At Islampur, Kamalganj, Moulvibazar.	SECTIONAL PLAN		

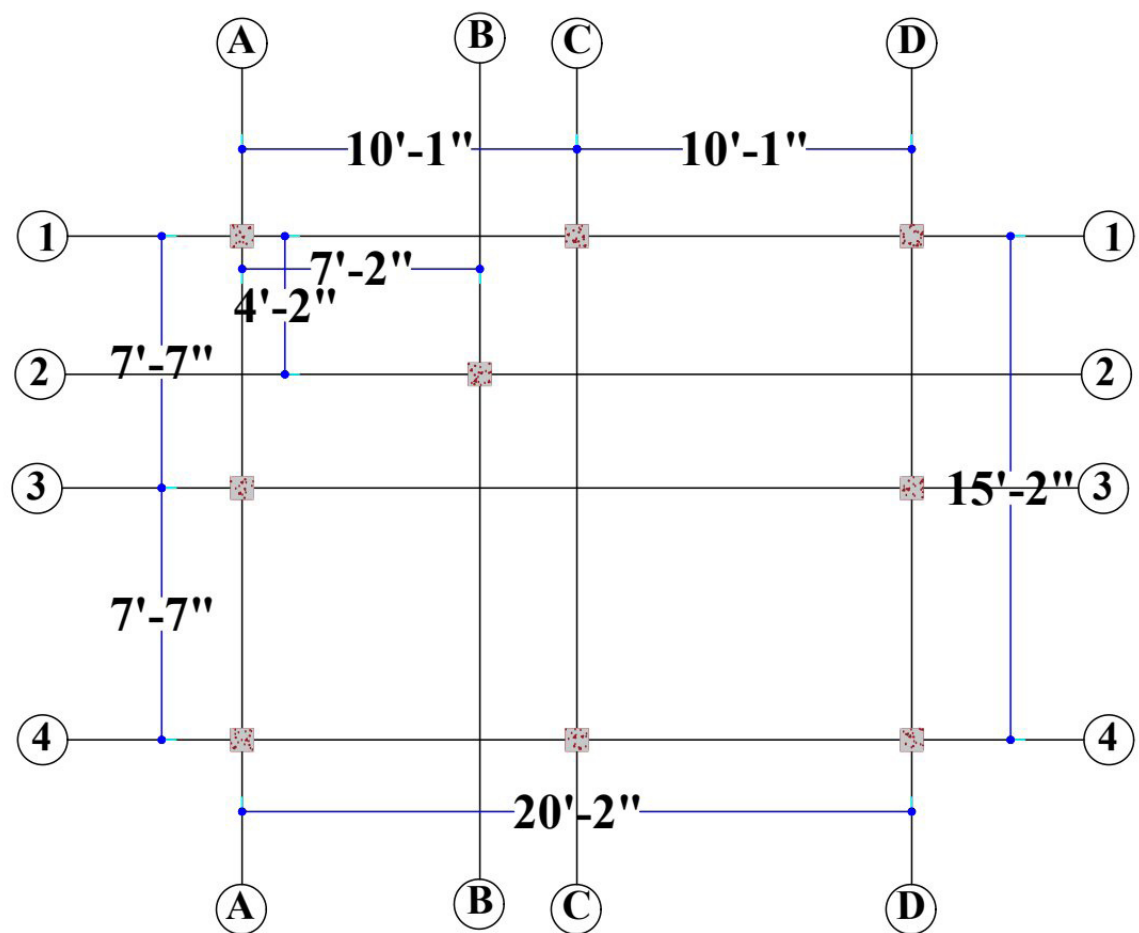


PAGE NO - 04

	PROJECT NAME.	ACTIVITIES NAME.	ACKNOWLEDGE BY.	DESIGN BY.
	Promoting Safe drinking water source and Menstrual Hygiene Management Facilities for Adolescents in school level at Moulvibazar CDP	Establish Adolescent Corner.	Education Protection & Health Team	Engr. Jaber Al Sabet. Technical Facilitator Good Neighbors Bangladesh Moulvi Bazar CDP. CALL:01613-080824
	PROJECT LOCATION.	DRAWING TITLE.		
	Kurma Tea garden Jr. School At Islampur,Kamalganj,Moulvibazar.	GRID LINE LAYOUT PLAN		
		DATE: July- 2026	SCALE: AS SHOWN	

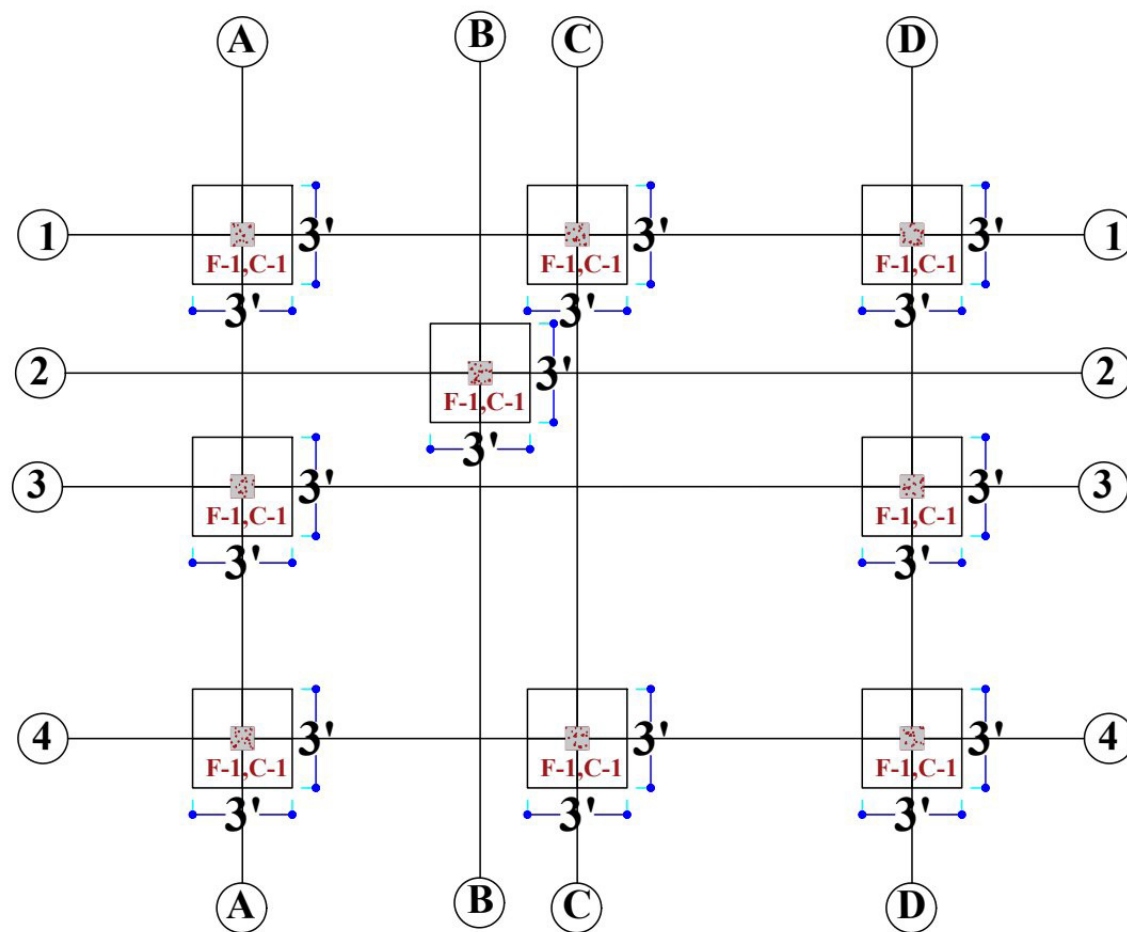

PAGE NO - 05

	PROJECT NAME.	ACTIVITIES NAME.	ACKNOWLEDGE BY.	DESIGN BY.
	Promoting Safe drinking water source and Menstrual Hygiene Management Facilities for Adolescents in school level at Moulvibazar CDP	Establish Adolescent Corner.	Education Protection & Health Team	Engr. Jaber Al Sabet. Technical Facilitator Good Neighbors Bangladesh Moulvi Bazar CDP. CALL:01613-080824
	PROJECT LOCATION.	DRAWING TITLE.		
	Kurma Tea garden Jr. School At Islampur, Kamalganj, Moulvibazar.	FOOTING & COLUMN LAYOUT PLAN	DATE: July- 2026 SCALE: AS SHOWN	

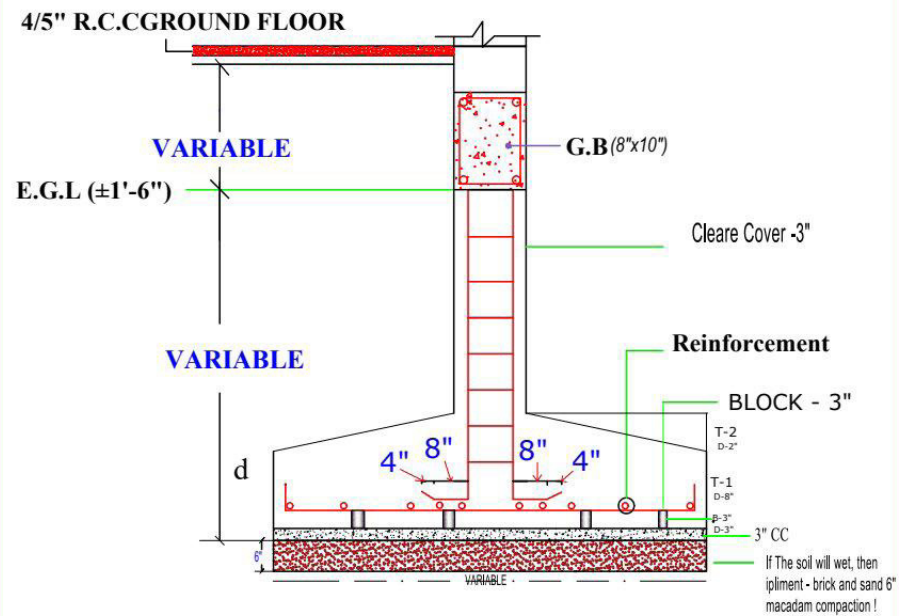

FOOTING TYPE	FOOTING SIZE	FOOTING THICKNESS T-1	FOOTING SLOPING T-2	FOOTING REINFORCEMENT
F-1 9-NOS	3'-0" x 3'-0"	8"	2"	10mm Ø @ 4.5" C/C Both way


NOT SOIL TEST REPORT .

PAGE NO - 06

	PROJECT NAME:	ACTIVITIES NAME:	ACKNOWLEDGE BY:	DESIGN BY:
	Promoting Safe drinking water source and Menstrual Hygiene Management Facilities for Adolescents in school level at Moulvibazar CDP	Establish Adolescent Corner.	Education Protection & Health Team	Engr. Jaber Al Sabet. Technical Facilitator Good Neighbors Bangladesh Moulvi Bazar CDP. CALL:01613-080824
	PROJECT LOCATION:	DRAWING TITLE:		
	Kurma Tea garden Jr. School At Islampur, Kamalganj, Moulvibazar.	FOOTING DETAIL PLAN		
			DATE: July 2025	SCALE: AS SHOWN


COLUMN SCHEDULE		
COLUMN TYPE	BELOW GROUND FLOOR	ABOVE GROUND FLOOR
C1-9 NOS	 02 - Ø 12 mm 02 - Ø 10 mm	 02 - Ø 12 mm 02 - Ø 10 mm

All tie use 8 mm rode

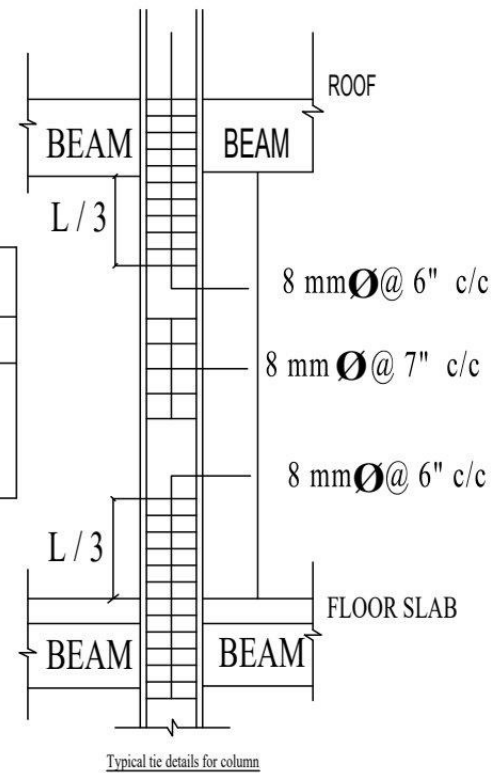


PAGE NO - 07

	PROJECT NAME:	ACTIVITIES NAME:	ACKNOWLEDGE BY:	DESIGN BY:
	Promoting Safe drinking water source and Menstrual Hygiene Management Facilities for Adolescents in school level at Moulvibazar CDP	Establish Adolescent Corner.	Education Protection & Health Team	Engr. Jaber Al Sabet, Technical Facilitator Good Neighbors Bangladesh Moulvi Bazar CDP CALL:01613-080824
	PROJECT LOCATION:	DRAWING TITLE:		
	Kurma Tea garden Jr. School At Islampur, Kamalganj, Moulvibazar.	COLUMN DETAIL PLAN		
	DATE: July 2025	SCALE: AS SHOWN		

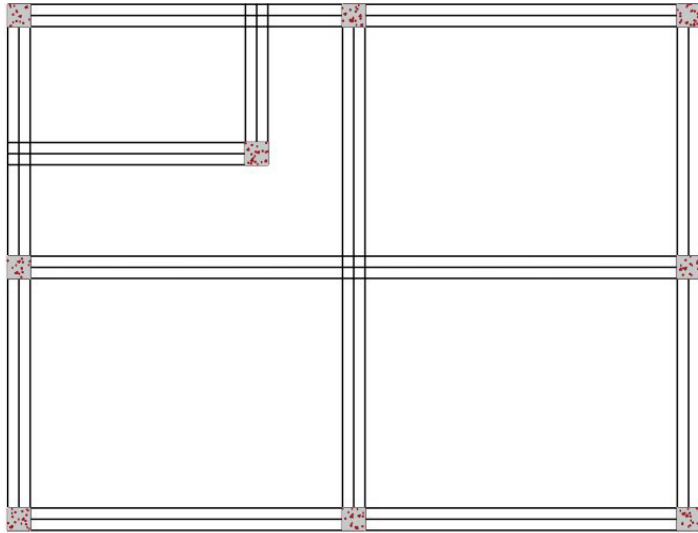


DRAWING TITLE:
GRADE BEAM LAYOUT
PLAN

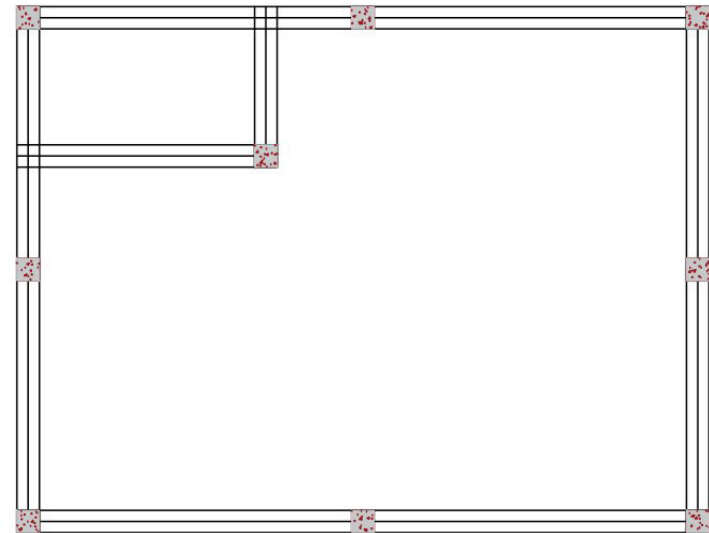


DRAWING TITLE:
F BEAM LAYOUT PLAN

PAGE NO - 08


	PROJECT NAME.	ACTIVITIES NAME.	ACKNOWLEDGE BY.	DESIGN BY.
	Promoting Safe drinking water source and Menstrual Hygiene Management Facilities for Adolescents in school level at Moulvibazar CDP	Establish Adolescent Corner.	Education Protection & Health Team	Engr. Jaber Al Sabet. Technical Facilitator Good Neighbors Bangladesh Moulvi Bazar CDP. CALL:01613-080824
	PROJECT LOCATION.	DRAWING TITLE.	 DATE: July- 2026 SCALE: AS SHOWN	
	Kurma Tea garden Jr. School At Islampur,Kamalganj,Moulvibazar.	BEAM LAYOUT PLAN		

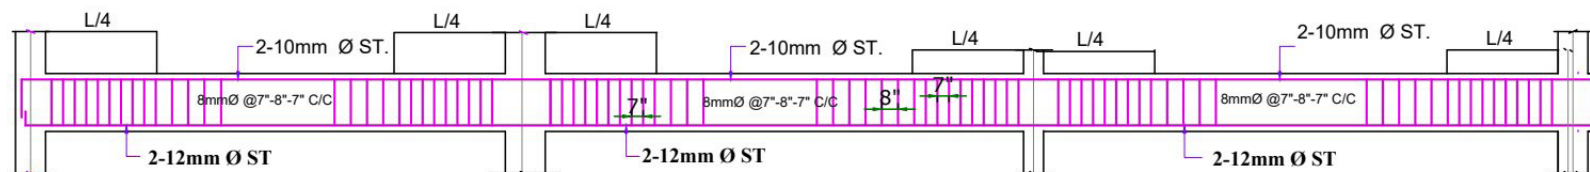


Section of G.B (8"x10")

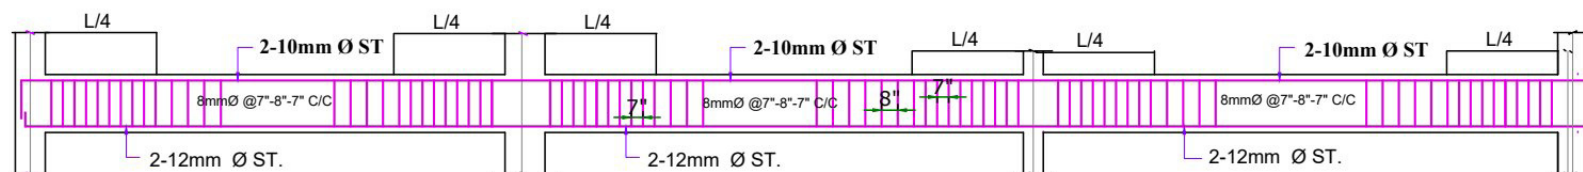

Section of F.B- (8"x9")

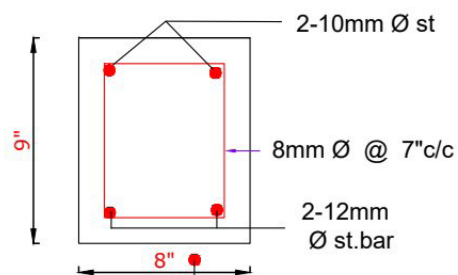


Section of F.B.-

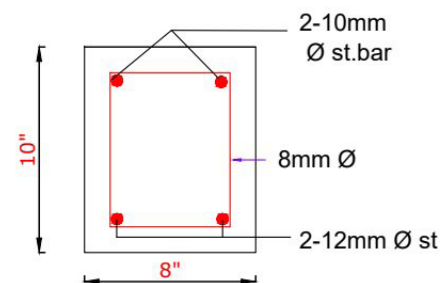

Section of G.B.


PAGE NO - 09

	PROJECT NAME.	ACTIVITIES NAME.	ACKNOWLEDGE BY.	DESIGN BY.
	Promoting Safe drinking water source and Menstrual Hygiene Management Facilities for Adolescents in school level at Moulvibazar CDP	Establish Adolescent Corner.	Education Protection & Health Team	Engr. Jaber Al Sabet. Technical Facilitator Good Neighbors Bangladesh Moulvi Bazar CDP. CALL:01613-080824
	PROJECT LOCATION.	DRAWING TITLE.	 DATE: July- 2026 SCALE: AS SHOWN	
	Kurma Tea garden Jr. School At Islampur,Kamalganj,Moulvibazar.	BEAM DETAIL PLAN		

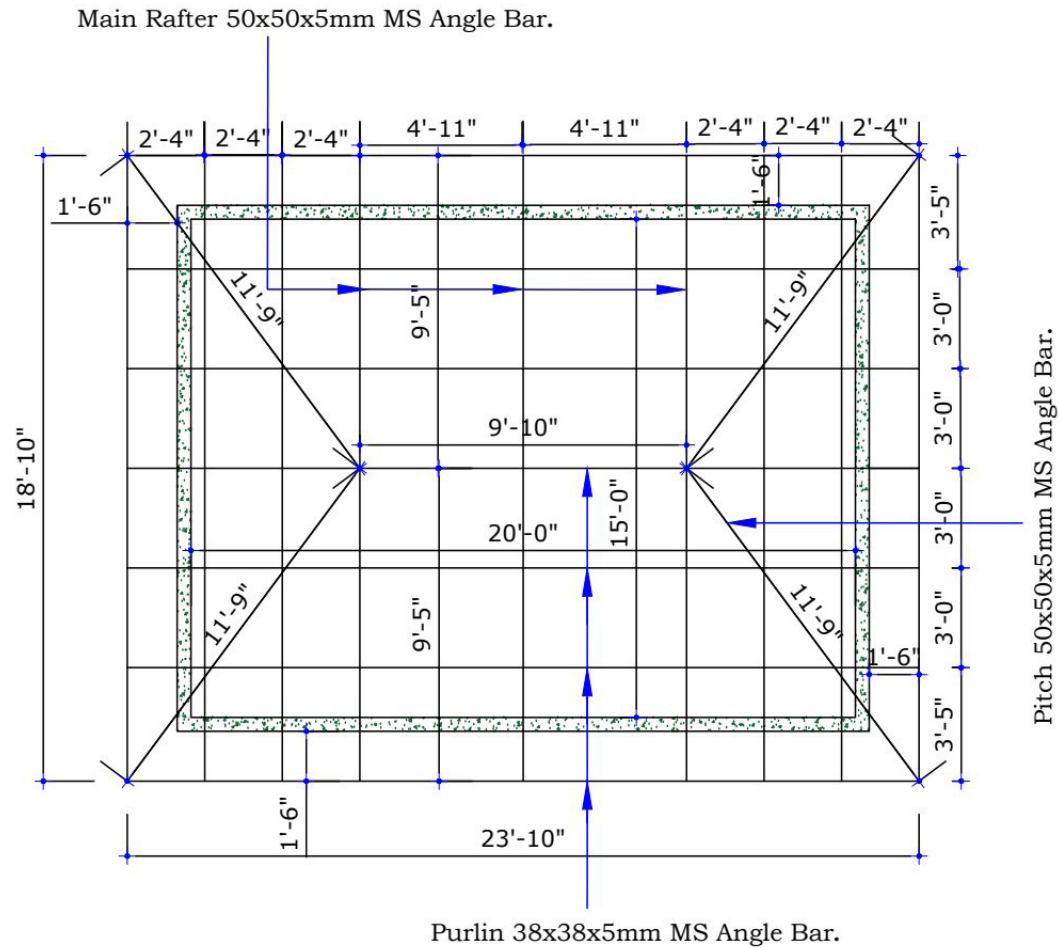


PAGE NO - 10

	PROJECT NAME.	ACTIVITIES NAME.	ACKNOWLEDGE BY.	DESIGN BY.
	Promoting Safe drinking water source and Menstrual Hygiene Management Facilities for Adolescents in school level at Moulvibazar CDP	Establish Adolescent Corner.	Education Protection & Health Team	Engr. Jaber Al Sabet. Technical Facilitator Good Neighbors Bangladesh Moulvi Bazar CDP. CALL:01613-080824
	PROJECT LOCATION.	DRAWING TITLE.		
	Kurma Tea garden Jr. School At Islampur, Kamalganj, Moulvibazar.	ROOF PLAN		
		DATE: July- 2026	SCALE: AS SHOWN	

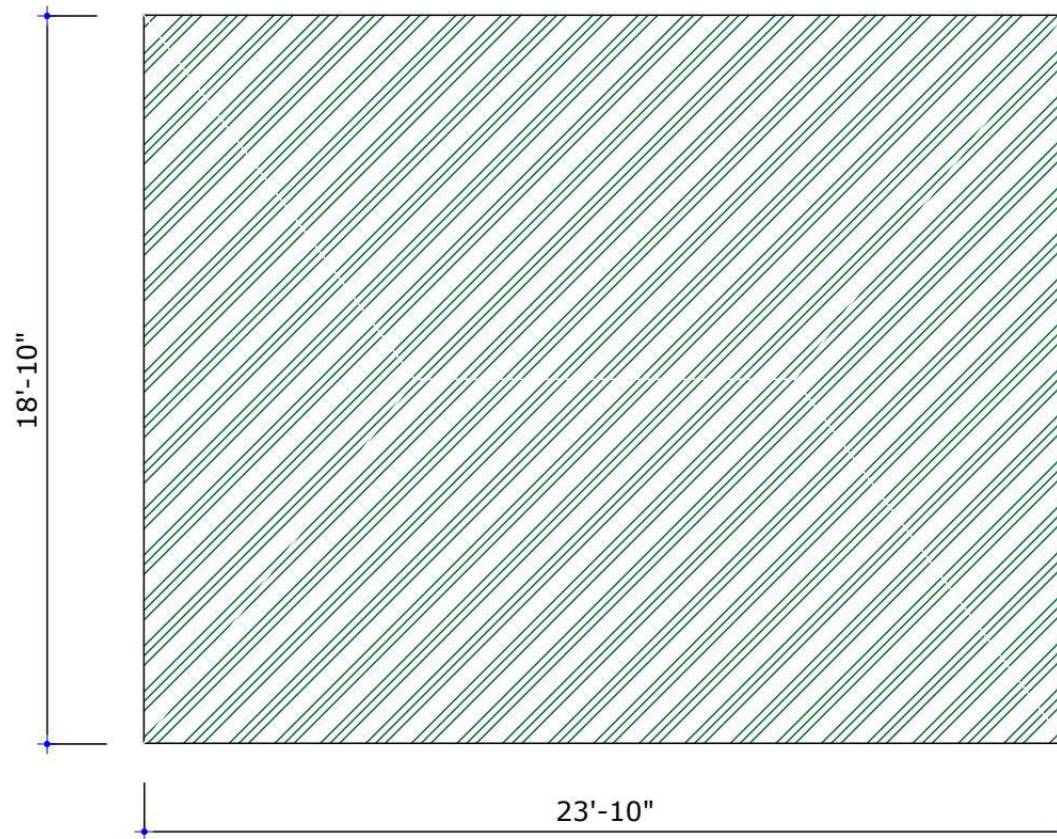


PAGE NO - 11

	PROJECT NAME.	ACTIVITIES NAME.	ACKNOWLEDGE BY.	DESIGN BY.
	Promoting Safe drinking water source and Menstrual Hygiene Management Facilities for Adolescents in school level at Moulvibazar CDP	Establish Adolescent Corner.	Education Protection & Health Team	Engr. Jaber Al Sabet. Technical Facilitator Good Neighbors Bangladesh Moulvi Bazar CDP. CALL:01613-080824
	PROJECT LOCATION.	DRAWING TITLE.	 DATE: July- 2026 SCALE: AS SHOWN	
	Kurma Tea garden Jr. School At Islampur,Kamalganj,Moulvibazar.	ROOF TOP VIEW		

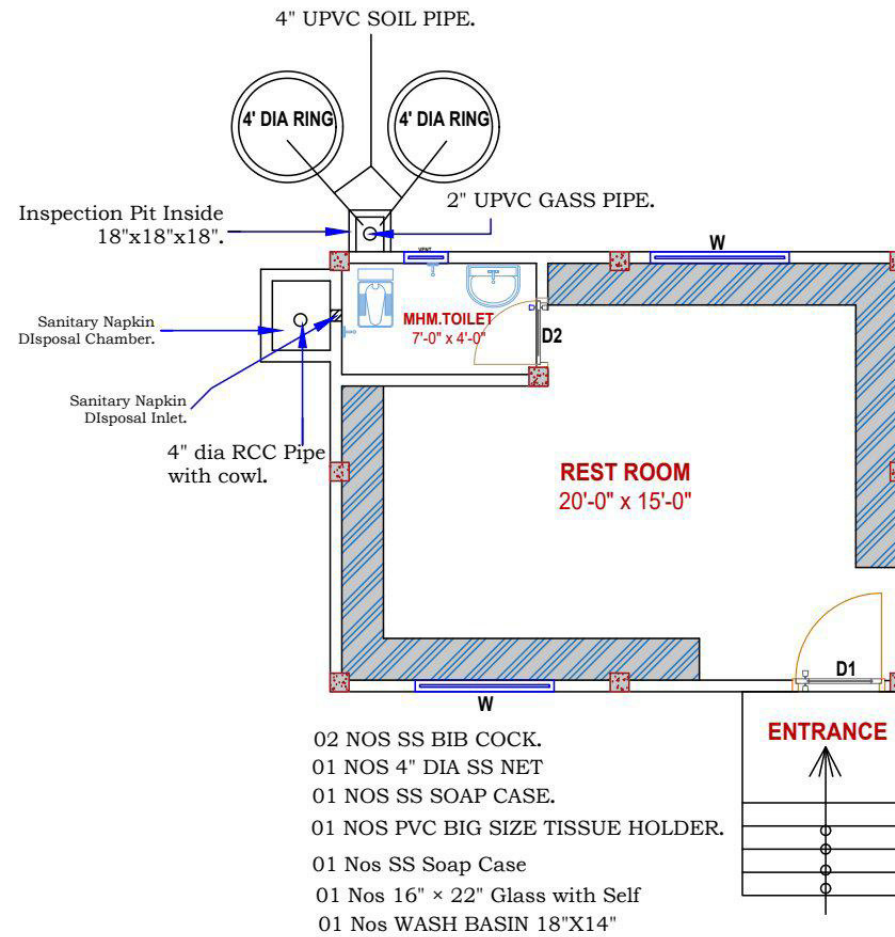

PAGE NO - 12

	PROJECT NAME.	ACTIVITIES NAME.	ACKNOWLEDGE BY.	DESIGN BY.
	Promoting Safe drinking water source and Menstrual Hygiene Management Facilities for Adolescents in school level at Moulvibazar CDP	Establish Adolescent Corner.	Education Protection & Health Team	Engr. Jaber Al Sabet. Technical Facilitator Good Neighbors Bangladesh Moulvi Bazar CDP. CALL:01613-080824
	PROJECT LOCATION.	DRAWING TITLE.	DATE: July- 2026	SCALE: AS SHOWN
	Kurma Tea garden Jr. School At Islampur,Kamalganj,Moulvibazar.	PLUMBING PLAN		

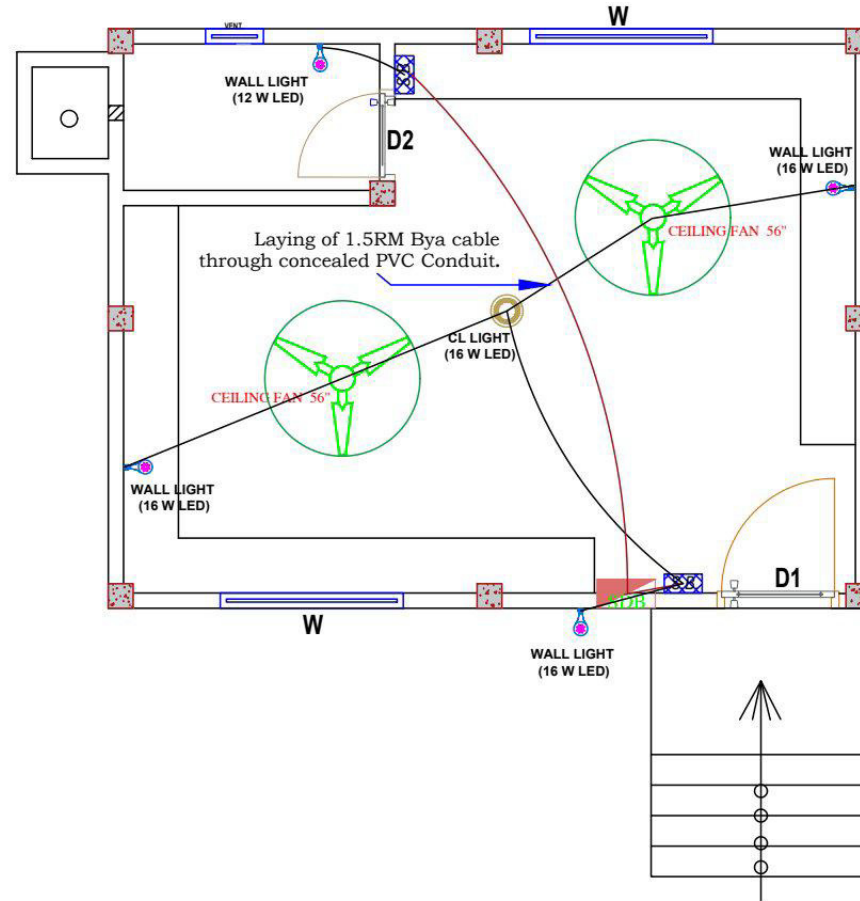

PAGE NO - 13

	PROJECT NAME.	ACTIVITIES NAME.	ACKNOWLEDGE BY.	DESIGN BY.
	Promoting Safe drinking water source and Menstrual Hygiene Management Facilities for Adolescents in school level at Moulvibazar CDP	Establish Adolescent Corner.	Education Protection & Health Team	Engr. Jaber Al Sabet. Technical Facilitator Good Neighbors Bangladesh Moulvi Bazar CDP. CALL:01613-080824
	PROJECT LOCATION.	DRAWING TITLE.	 DATE: July- 2026 SCALE: AS SHOWN	
	Kurma Tea garden Jr. School At Islampur,Kamalganj,Moulvibazar.	ELECTRICAL PLAN		